
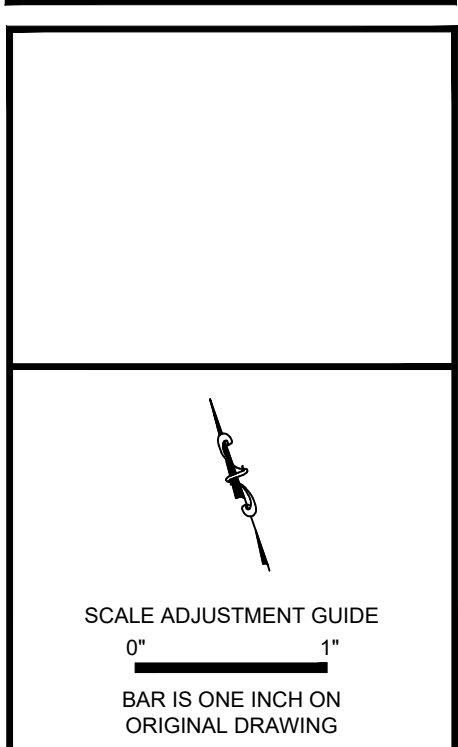
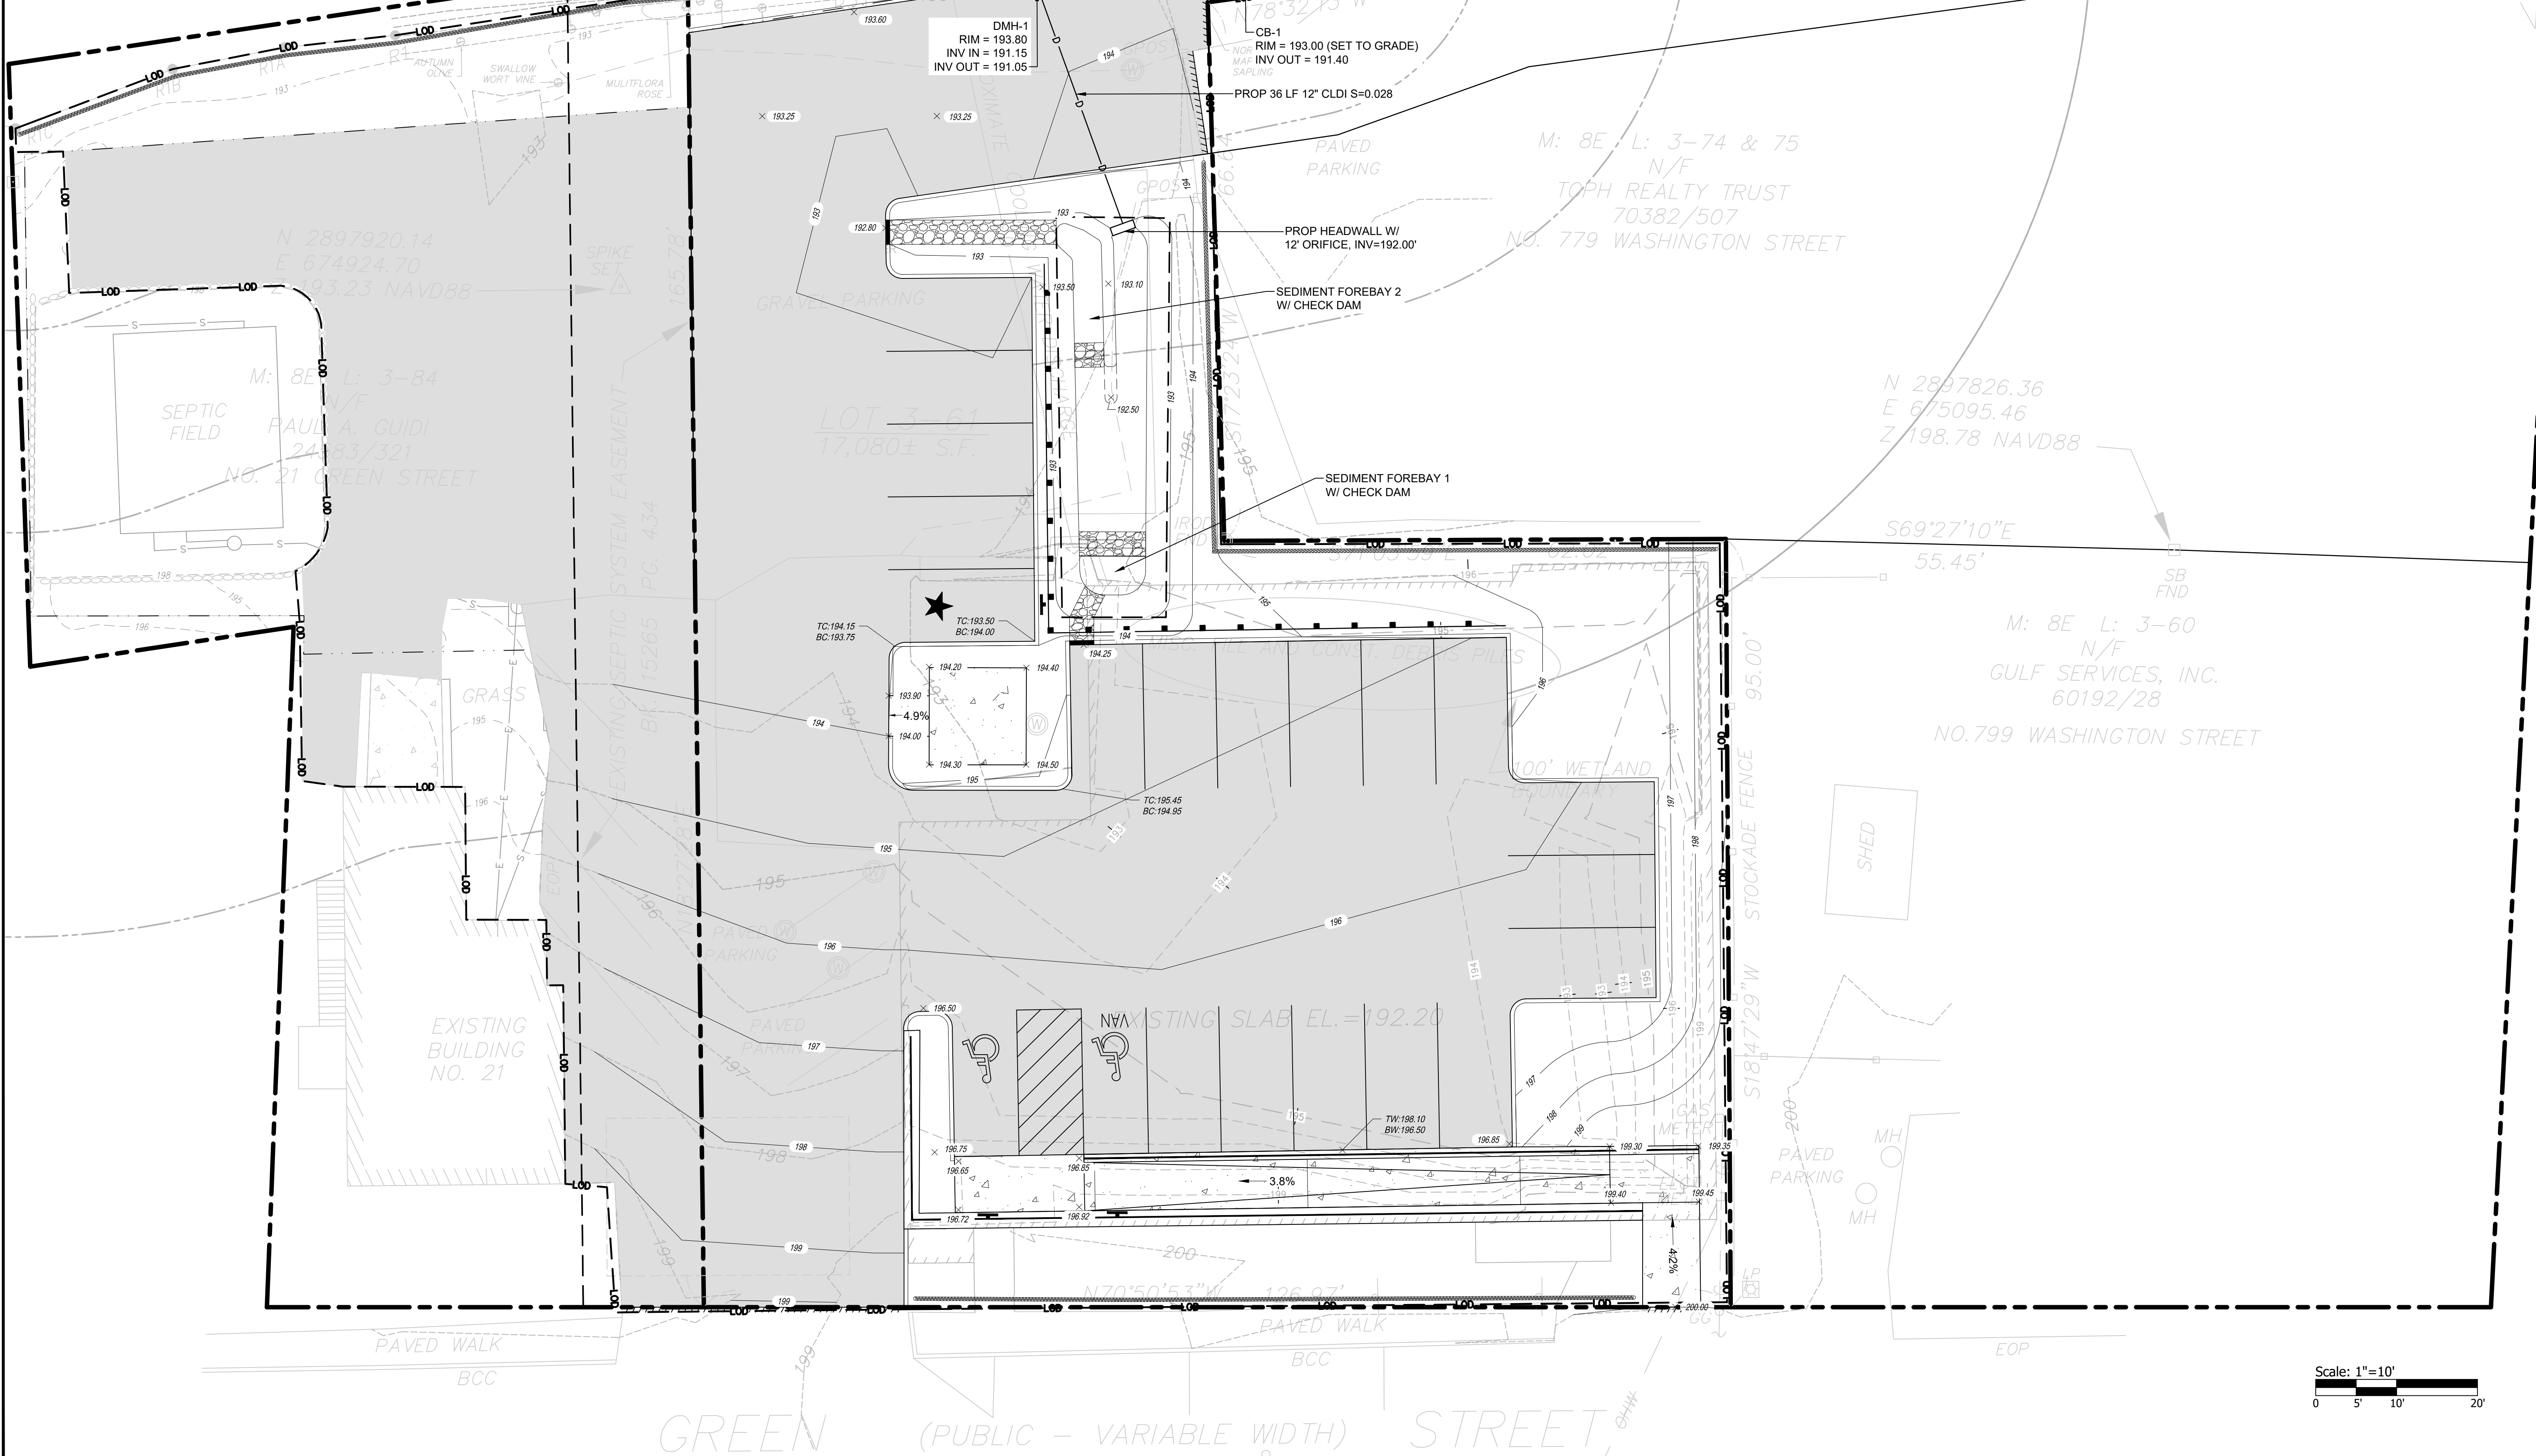


1. ALL CATCH BASINS AND DRAIN MANHOLES SHALL BE 4' DIA. PRECAST CONCRETE UNLESS NOTED OTHERWISE.
2. ALL DRAIN PIPES SHALL BE SMOOTH INTERIOR CORRUGATED HIGH DENSITY POLYETHYLENE UNLESS NOTED OTHERWISE.
3. REINFORCED CONCRETE PIPE (RCP) SHALL BE CLASS III UNLESS NOTED OTHERWISE.
4. ALL SLOPES PROVIDED ARE FT/FT.
5. ALL CATCH BASINS AND AREA DRAINS SHALL BE INSTALLED WITH A SUMP AND OUTLET HOOD PER THE DETAIL.
6. ALL SEWER MANHOLES SHALL BE 4' DIA. UNLESS NOTED OTHERWISE.
7. REFER TO ELECTRICAL DRAWINGS FOR INFORMATION ON ELECTRIC AND TEL/DATA DUCT BANKS AND STRUCTURES. ALL ELECTRICAL FACILITIES DISPLAYED FOR REFERENCE ONLY.
8. REPAIR OR REPLACE DAMAGED IRRIGATION FACILITIES TO PRE-CONSTRUCTION CONDITIONS AT NO ADDITIONAL COST TO THE OWNER.
9. MODIFICATIONS AND REPAIRS TO THE EXISTING IRRIGATION SYSTEM AND SUPPLY WATER SERVICE SHALL BE DESIGNED, FURNISHED AND INSTALLED BY THE CONTRACTOR. THIS INCLUDES ALL WATER AND ELECTRICAL COMPONENTS INSTALLED PER MANUFACTURERS RECOMMENDATIONS.
10. REFER TO "CIVIL NOTES AND LEGEND" FOR ADDITIONAL NOTES.

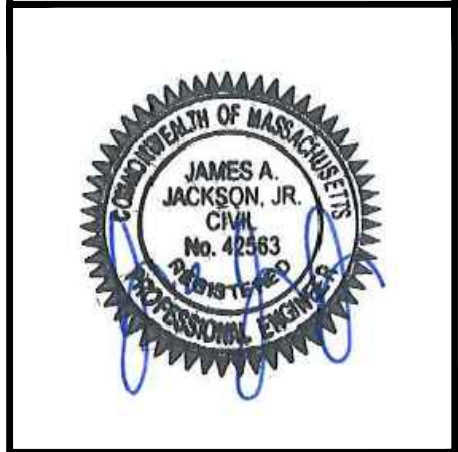

Town of Holliston
9 Green Street
Holliston, Massachusetts

[illegible]

PROJECT NO.:	20212.00
DATE:	OCTOBER 2022
SCALE:	1"=10'
DESIGNED BY:	GLH
CHECKED BY:	SL
DRAWN BY:	AWB
APPROVED BY:	JAJ
DRAWING TITLE:	

DRAINAGE & UTILITY PLAN

DRAWING NO.:
C5.1
SHEET NO. 6 OF 10